
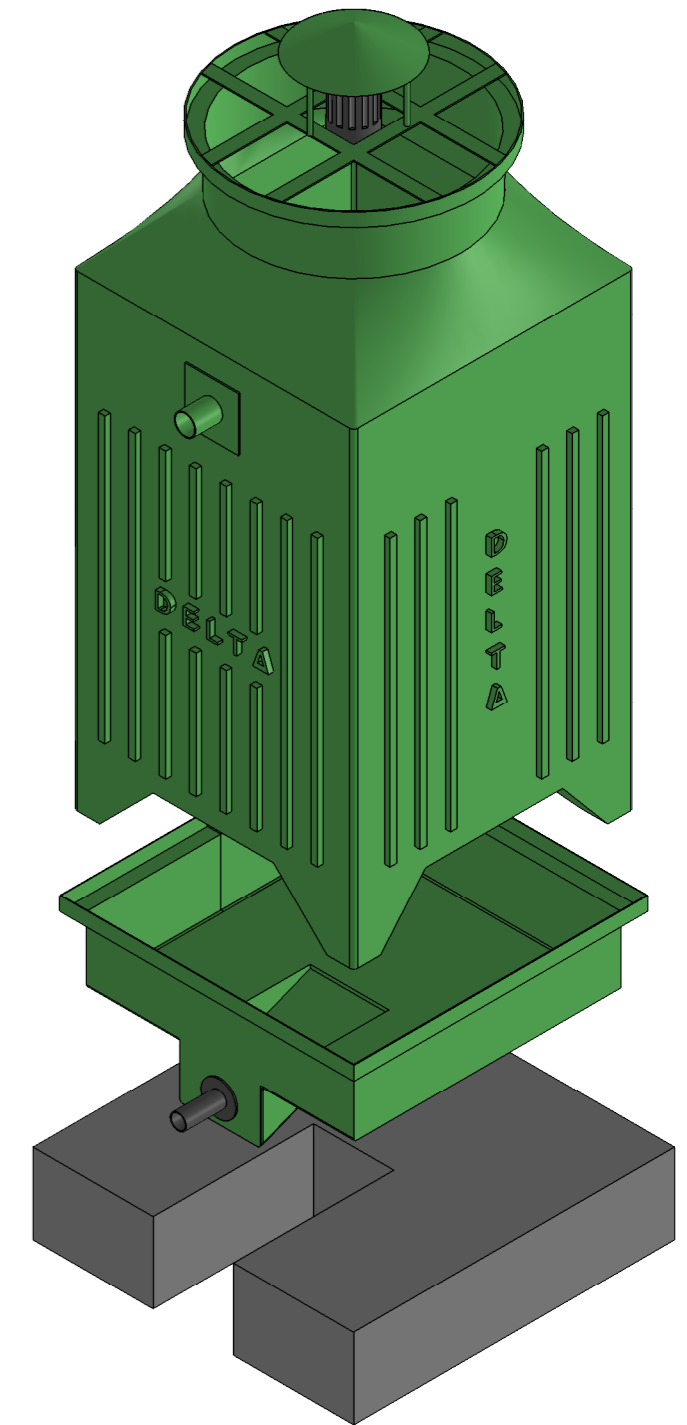


Foundation Plan From Top

Sr.No.	Description	6020 Sizes	6025 Sizes
1	Inlet Pipe Connection	50	65
2	Outlet Connection	50	65
3	Drain & Over Flow	15	15
4	Fan Dia	700	700

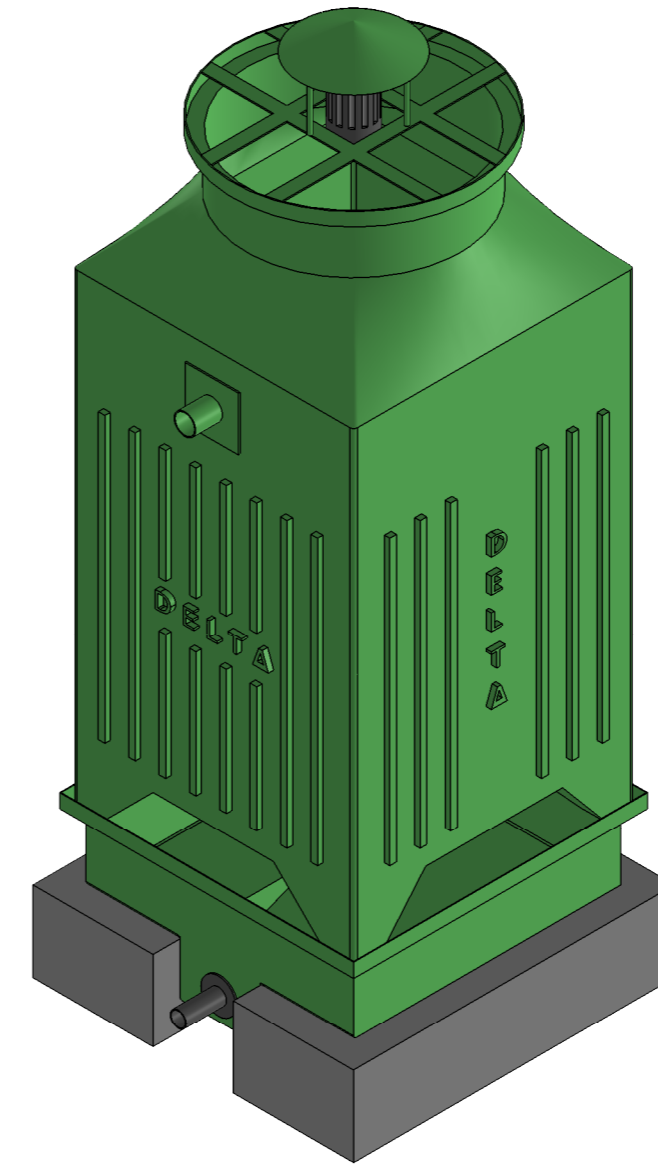

Exploded View

Notes:

1. All Dimensions are in Millimeters Unless Otherwise Stated.
2. Makeup & Quickfill Connection to be provided with thread connections as per IS-544-1955.
3. Inlet & Outlet Connections to be provided without Flanges.
4. Location of Outlet Connection as per Site Requirement.
5. PCC Platform of 300mm is under Purchaser Scope.

Delta Cooling Towers Pvt. Ltd			
DRAWN	DesignOnContract	G.A Drawing of Cooling Tower Model No. -6020 & 6025 DFC 60 Series	
CHKD	Yogesh M.Kaura		
APPVD	Yogesh M.Kaura		
DWG NO.		A3	Rev-0
MOD-----			
SCALE: Not To Scale		SHEET 1 OF 4	