
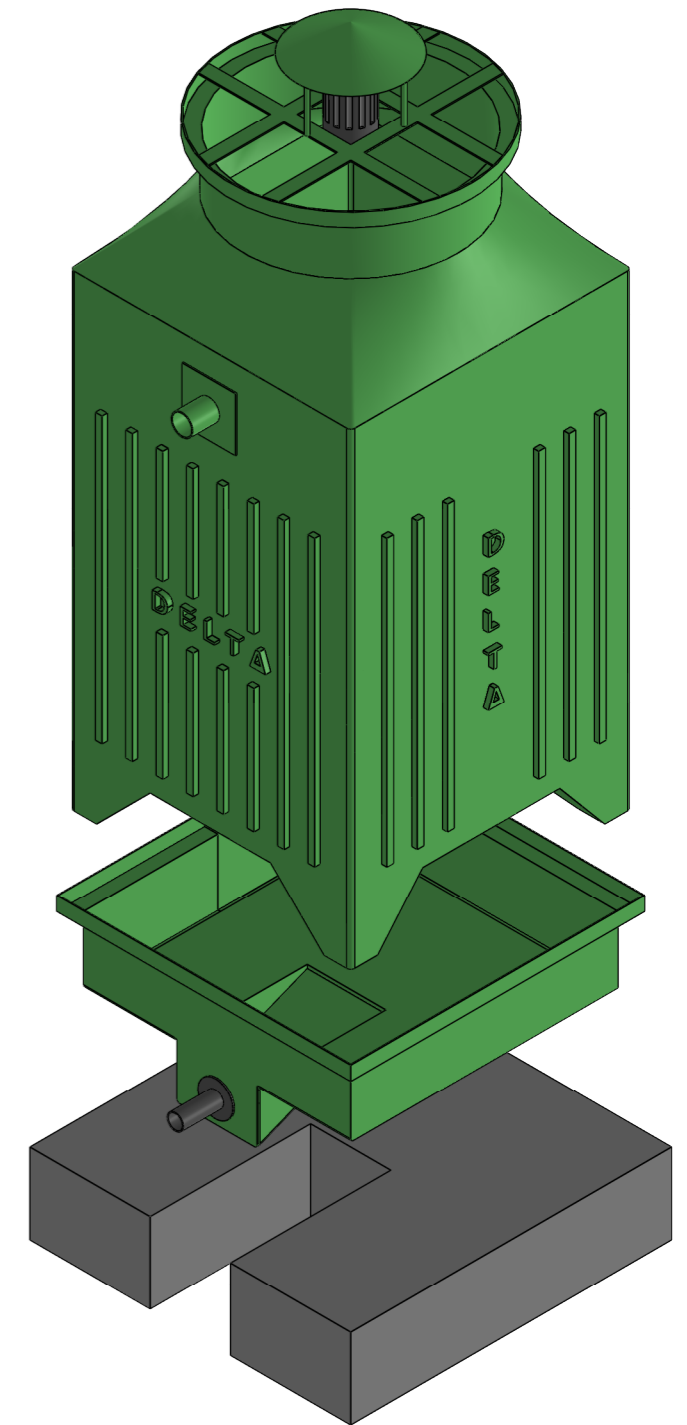


Foundation Plan From Top

Sr.No.	Description	Sizes
1	Inlet Pipe Connection	100
2	Outlet Connection	100
3	Drain & Over Flow	20
4	Fan Dia	1200

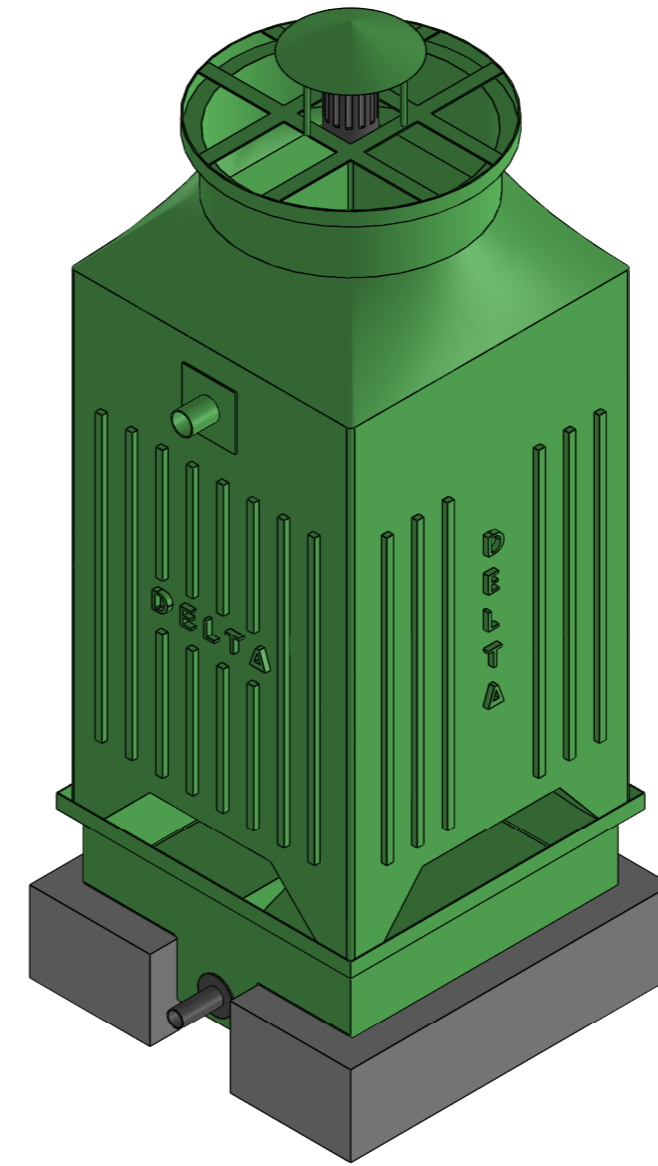

Exploded View

Notes:

1. All Dimensions are in Millimeters Unless Otherwise Stated.
2. Makeup & Quickfill Connection to be provided with thread connections as per IS-544-1955.
3. Inlet & Outlet Connections to be provided without Flanges.
4. Location of Outlet Connection as per Site Requirement.
5. PCC Platform of 300mm is under Purchaser Scope.

Delta Cooling Towers Pvt. Ltd			
DRAWN	DesignOnContract	G.A Drawing of Cooling Tower Model No. -6060 & 6070 DFC 60 Series	
CHK'D	Yogesh M.Kaura		
APP'VD	Yogesh M.Kaura		
DWG NO.		A3	Rev-0
MOD-----			
SCALE: Not To Scale		SHEET 4 OF 4	